


- Notes
1. Copyright Reserved
 2. Work to figured dimensions only. Do not scale drawing.
 3. The contractor is responsible for checking all levels and dimensions on site and shall refer all discrepancies to the Architect
 4. Where appropriate, for details of r.c. structure, or mechanical and electrical details, see Engineers drawings
 5. Proprietary items shall be fixed in strict accordance with manufacturers instructions.
 6. Sizes of proprietary items shall be checked with manufacturer.
 7. The contractor shall be responsible for the coordination of structure, finishes and services.

OSi PLACE Map

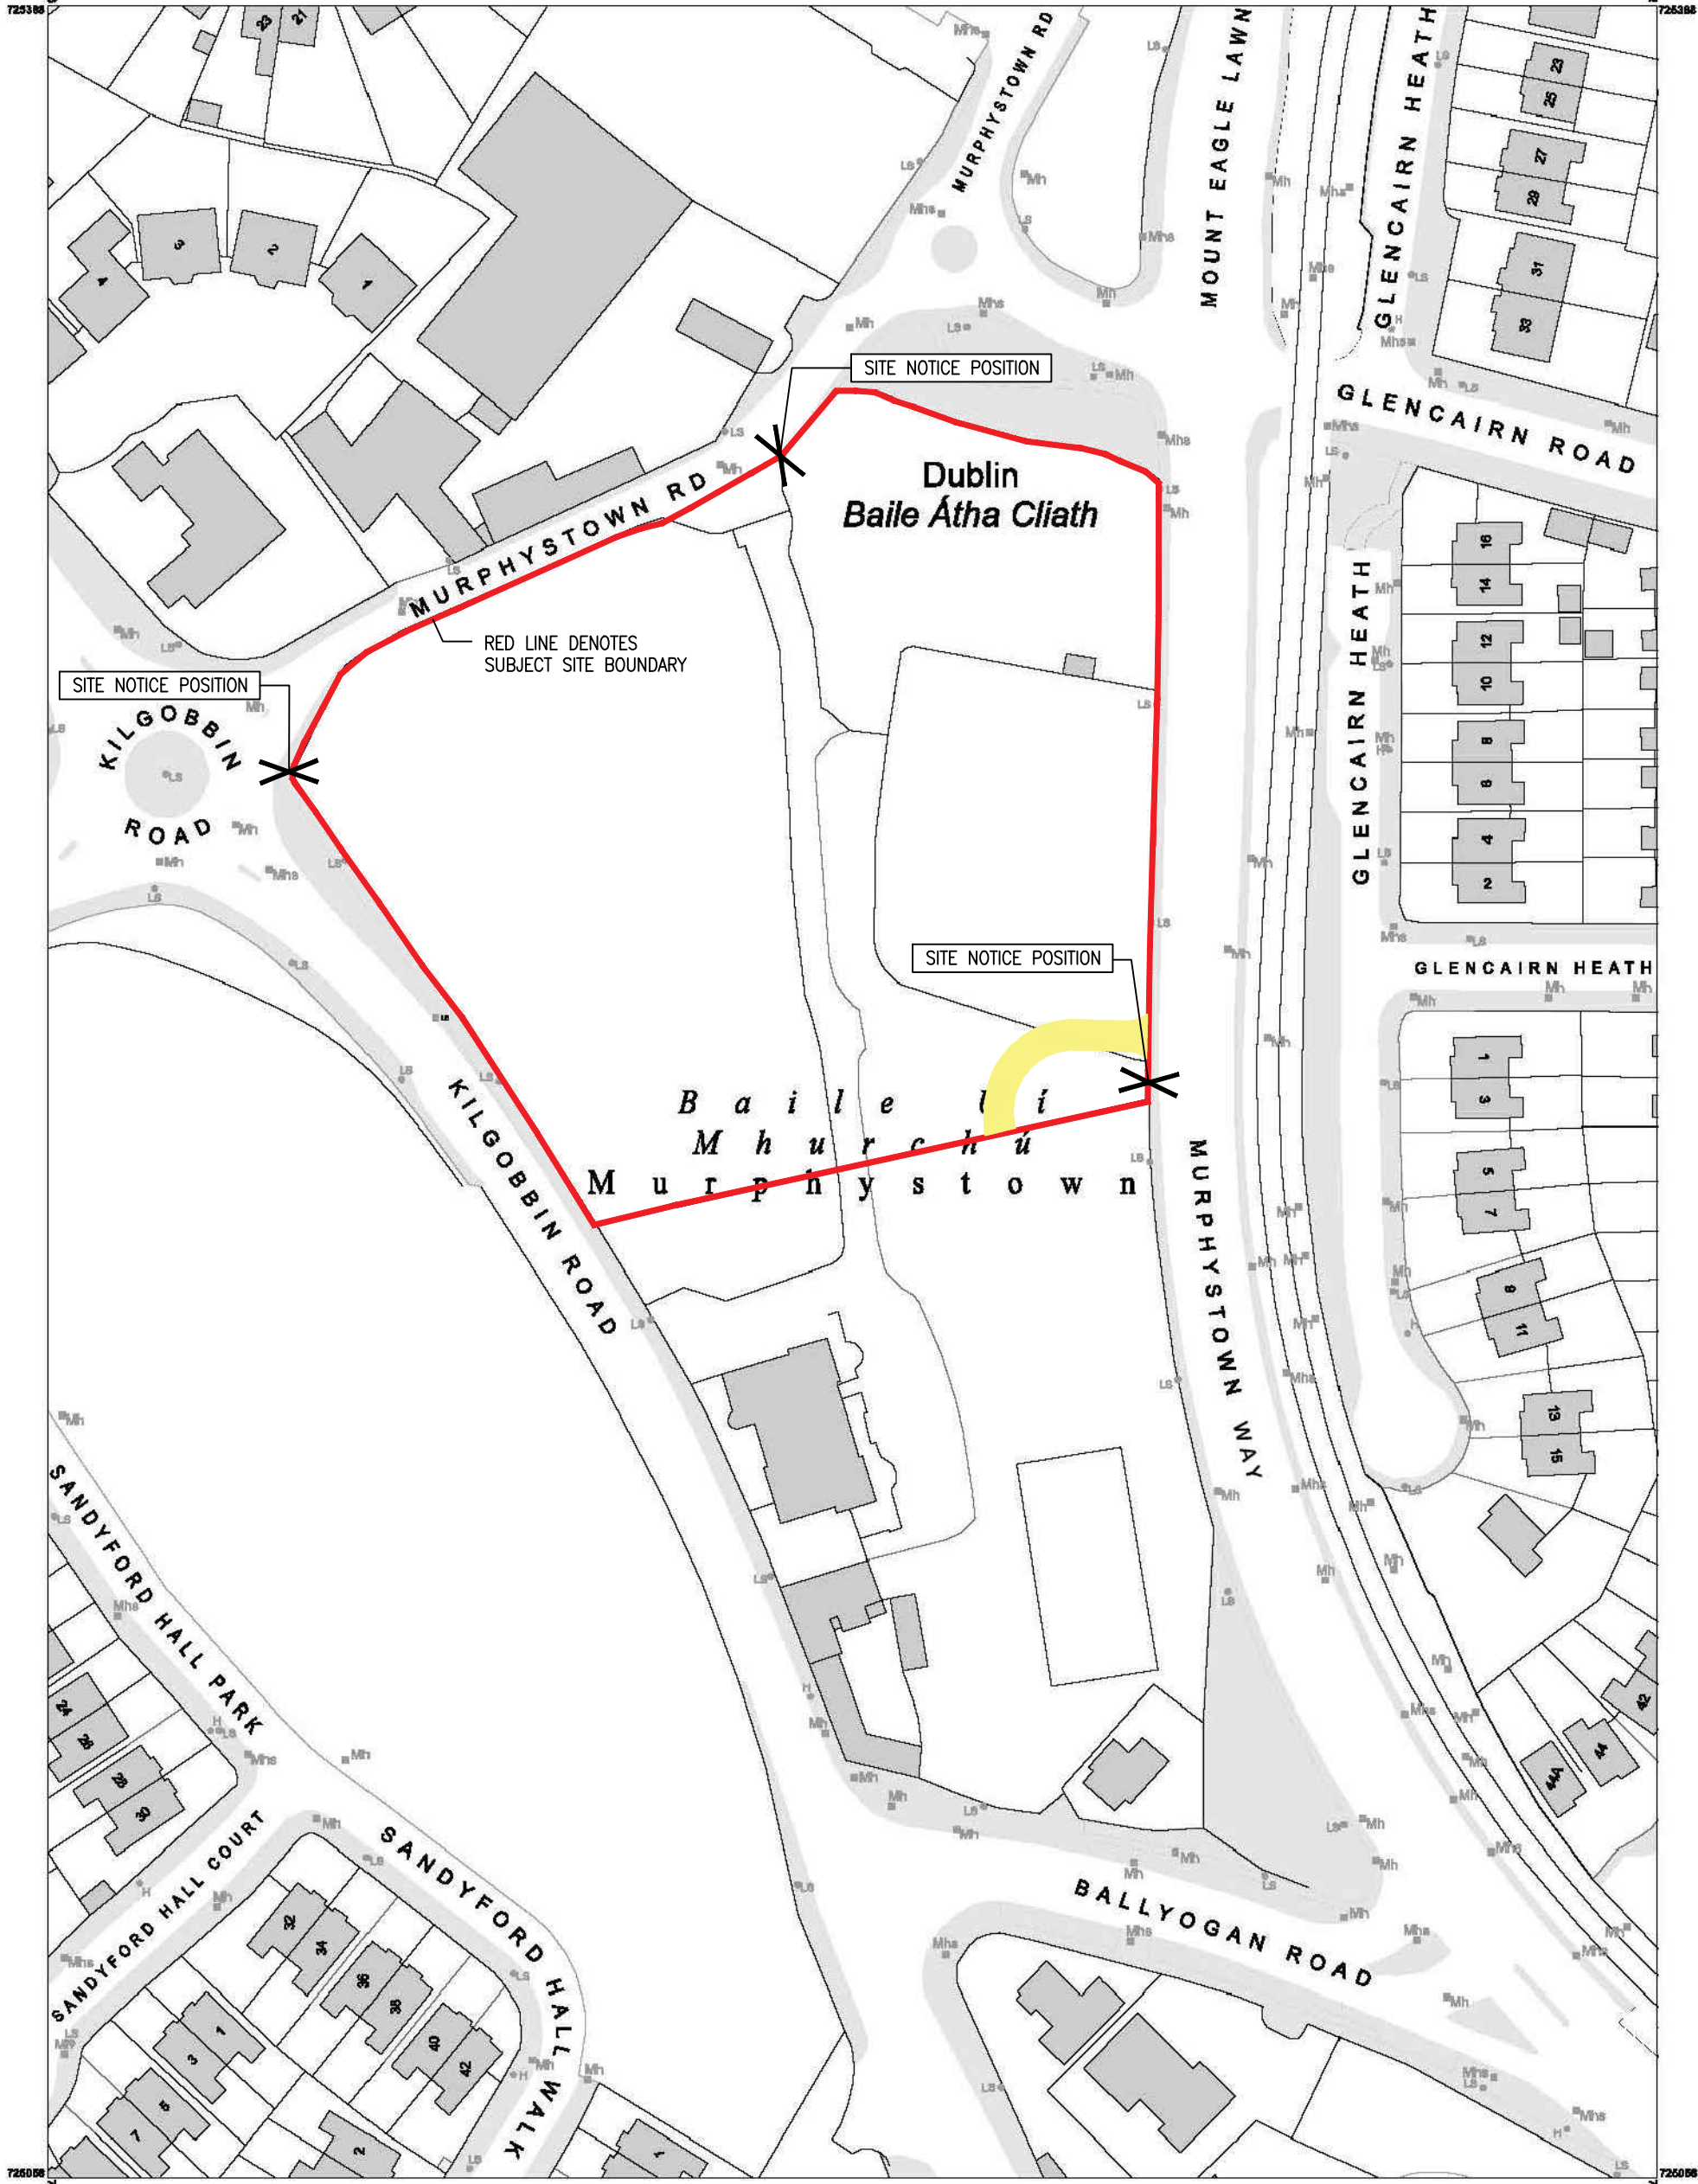

LEGEND

RED LINE DENOTES
SUBJECT SITE BOUNDARY

X SITE NOTICE POSITION

WAYLEAVE SHOWN HATCHED
YELLOW

SITE AREA

SITE AREA - 11967M2
(1.19 ha)

BKD LICENCE NO. DIGITALLY
REPRODUCED UNDER LICENCE
NUMBER: CYAL50393016
© NATIONAL MAPPING DIVISION
OF TAILTE ÉIREANN

(O.S. SHEET NUMBERS: 3455-10)

COMPILED AND PUBLISHED BY:
Ordnance Survey Ireland,
Phoenix Park,
Dublin 8,
Ireland.

All rights reserved.
No part of this publication may
be copied, reproduced
or transmitted in any form
or by any means without the prior
written permission of
the copyright owners.

Ordnance Survey maps
never show legal property
boundaries, nor do they
show ownership of
physical features.

MAP SERIES:
1:1,000

CENTRE
COORDINATES:
ITM 719289,725222

ORDER NO.:
50028544_1
PUBLISHED:
08/10/2018
©Suirbhéireacht Ordánais Éireann, 2018
©Ordnance Survey Ireland, 2018
www.osi.ie/copyright

MAP SHEETS:
3455-10

CAPTURE RESOLUTION:
The map objects are only accurate to the
resolution at which they were captured.
Output scale is not indicative of data capture scale.
Further information is available at:
<http://www.osi.ie>; search 'Capture Resolution'

LEGEND:
<http://www.osi.ie>; search 'Large Scale Legend'



Issue Status	No.	Date	Revision	Init.
Progress	P01	06.10.23	Planning App	MG
Planning Application	P02	27.03.2024	Planning App	FF
Fire Cert	P03	09.07..2024	Planning Application	FF
Disability Cert				
Tender				
Construction				
As Built				
Information Only				

M:\Project Section - Current\6275 Lisieux Hall\CAD\Planning\11) Boundary Walls Planning App\LIS-BKD-ZZ-ZZ-M2-A-0001_Site Location Map.dwg 06/09/2024 11:19:57

Project	Drawing Title	Stage	Scale	Drawn	Apd	Date
RESIDENTIAL APARTMENTS, LISIEUX PARK Murphystown Road, Leopardstown, Dublin 18	SITE LOCATION MAP	PLANNING	1:1000@A2	MG	FF	14.02.23
Project Code 6275	Job LIS	origin - BKD	zone - ST	level - ZZ	type - DR	dis - A
	sheet no. 0001	status P3	rev P03			

6-7 HARCOURT TERRACE, DUBLIN 2, IRELAND
t +353-1-618 2400 f +353-1-618 7366
e architecture@bkd.ie

www.bkd.ie

bkdarchitects
BURKE-KENNEDY DOYLE