


1 Existing Wall from Murphystown Way
1:200


BOUNDARY WALL LEGEND	
	RANDOM RUBBLE NATURAL STONE CLAD CONCRETE WALL
	RENDERED CONCRETE BLOCKWORK WALL
	NATURAL STONE WALL RENDERED




2 Permitted Boundary Treatment from Murphystown Way
1:200 PERMITTED UNDER PLANNING APPLICATION ABP-307415-20 AND ITS SUBSEQUENT AMENDMENTS

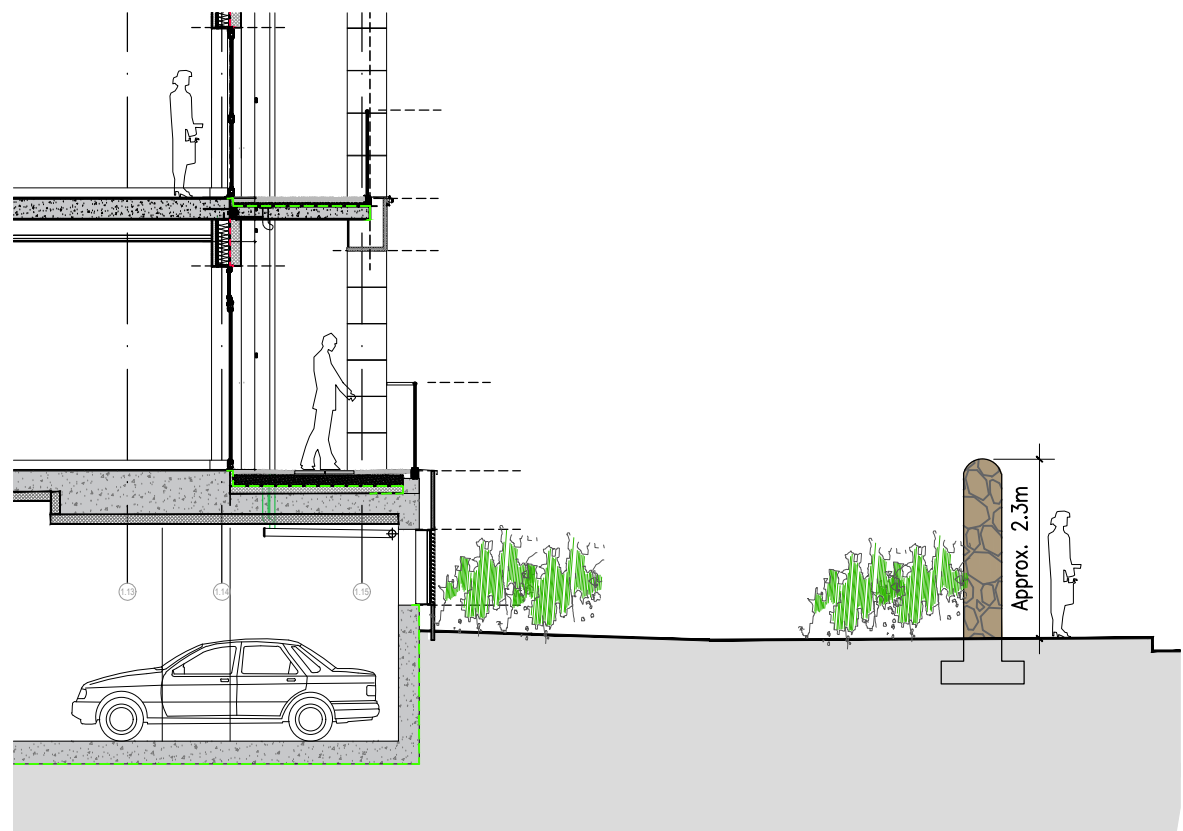

4 Proposed Boundary Treatment from Murphystown Way Section
1:100

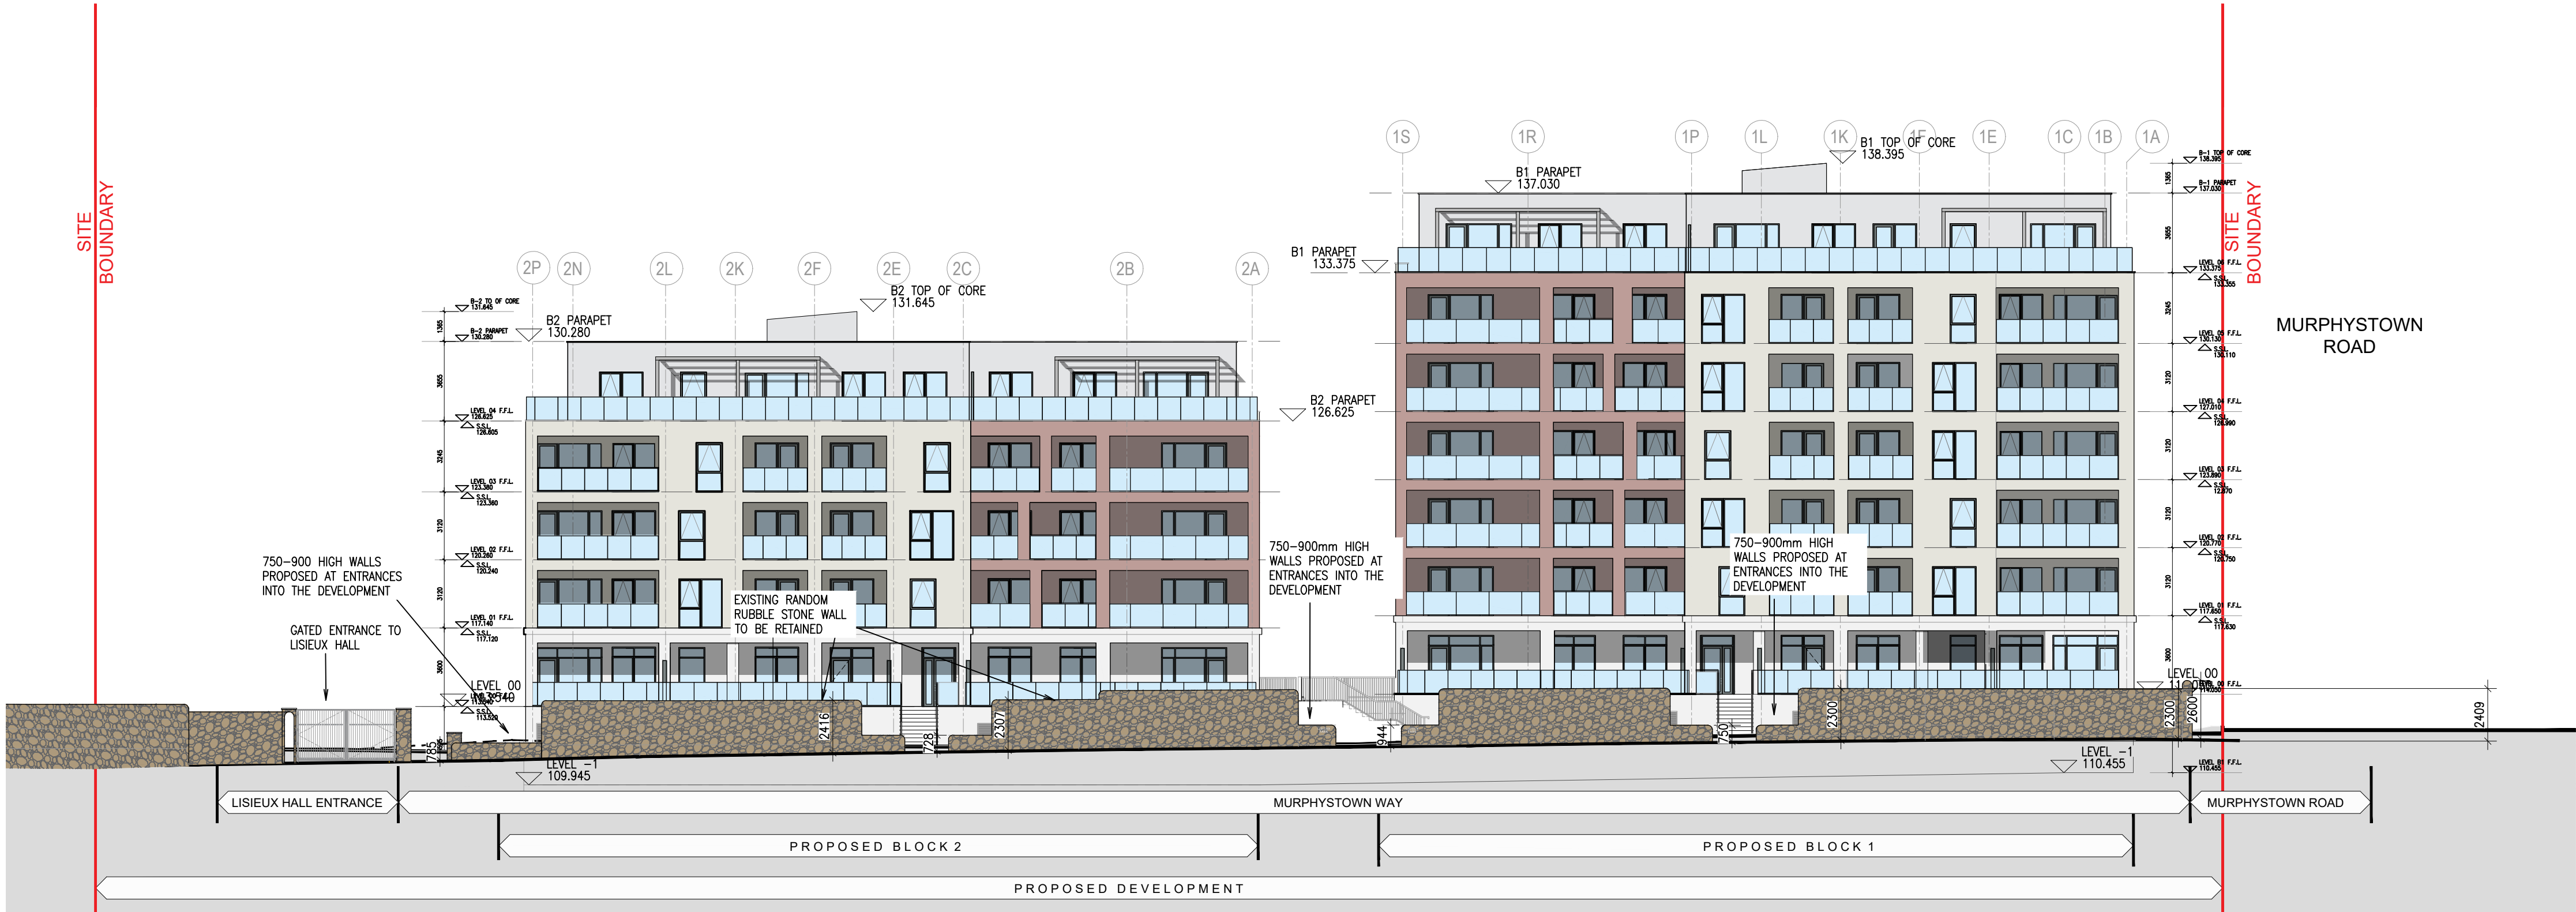

3 Proposed Boundary Treatment from Murphystown Way
1:200

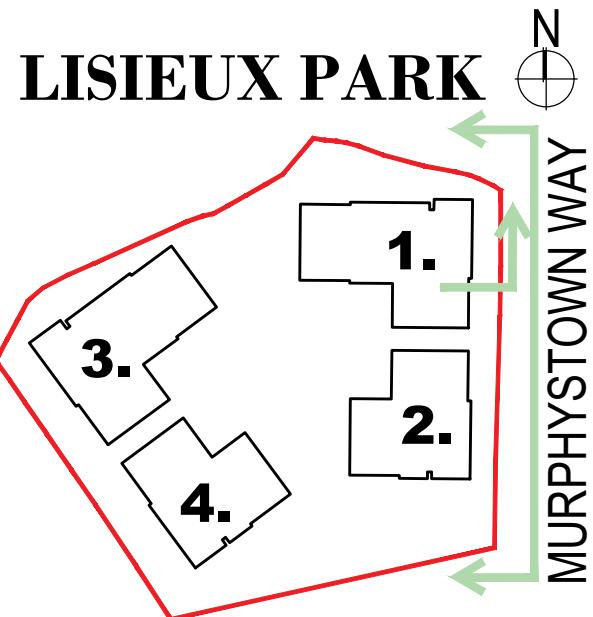

Permitted & Proposed

Notes		Issue Status		No.		Date		Revision		Initials	
1. Copyright Reserved		Progress		P01		09.07.24		Planning Application		FF	
2. Work to figure dimensions only. Do not scale drawing.		Planning Application									
3. The contractor is responsible for checking all levels and dimensions on site and shall refer all discrepancies to the Architect.		Fire Cert									
4. Where appropriate, for details of r.c. structure, or mechanical and electrical details, see Engineers drawings.		Disability Cert									
5. Proprietary items shall be fixed in strict accordance with manufacturers instructions.		Tender									
6. Sizes of proprietary items shall be checked with manufacturer.		Construction									
7. The contractor shall be responsible for the coordination of structure, finishes and services.		As Built									
M:\Project Section - Current\6275 Lisieux Hall\CAD\Planning\111 Boundary Walls Planning App\Boundary Walls Planning, Aug 24.dwg		Information Only									

Project		6-7 HARDCOURT TERRACE, DUBLIN 2, IRELAND	
RESIDENTIAL APARTMENTS, LISIEUX PARK		11 363 1 618 2100 11 363 1 676 7385	
Murphystown Road, Leopardstown, Dublin 18		www.bkd.ie	
Drawing Title		Permitted and Proposed Boundary Walls Treatment	
Stage	Planning	Scale	1:200@A1
Project Code	6275	Job	LIS - BKD - ZZ - ZZ - DR - A -
		Zone	ZZ
		Level	DR
		Type	A
		Sheet no.	2500
		Status	--
		Rev	P01
Date		09/07/2024	
Drawn		FF	
Appd		SR	
Date		09/07/2024	
Project Code		6275	
Job		LIS - BKD - ZZ - ZZ - DR - A -	
Zone		ZZ	
Level		DR	
Type		A	
Sheet no.		2500	
Status		--	
Rev		P01	

