


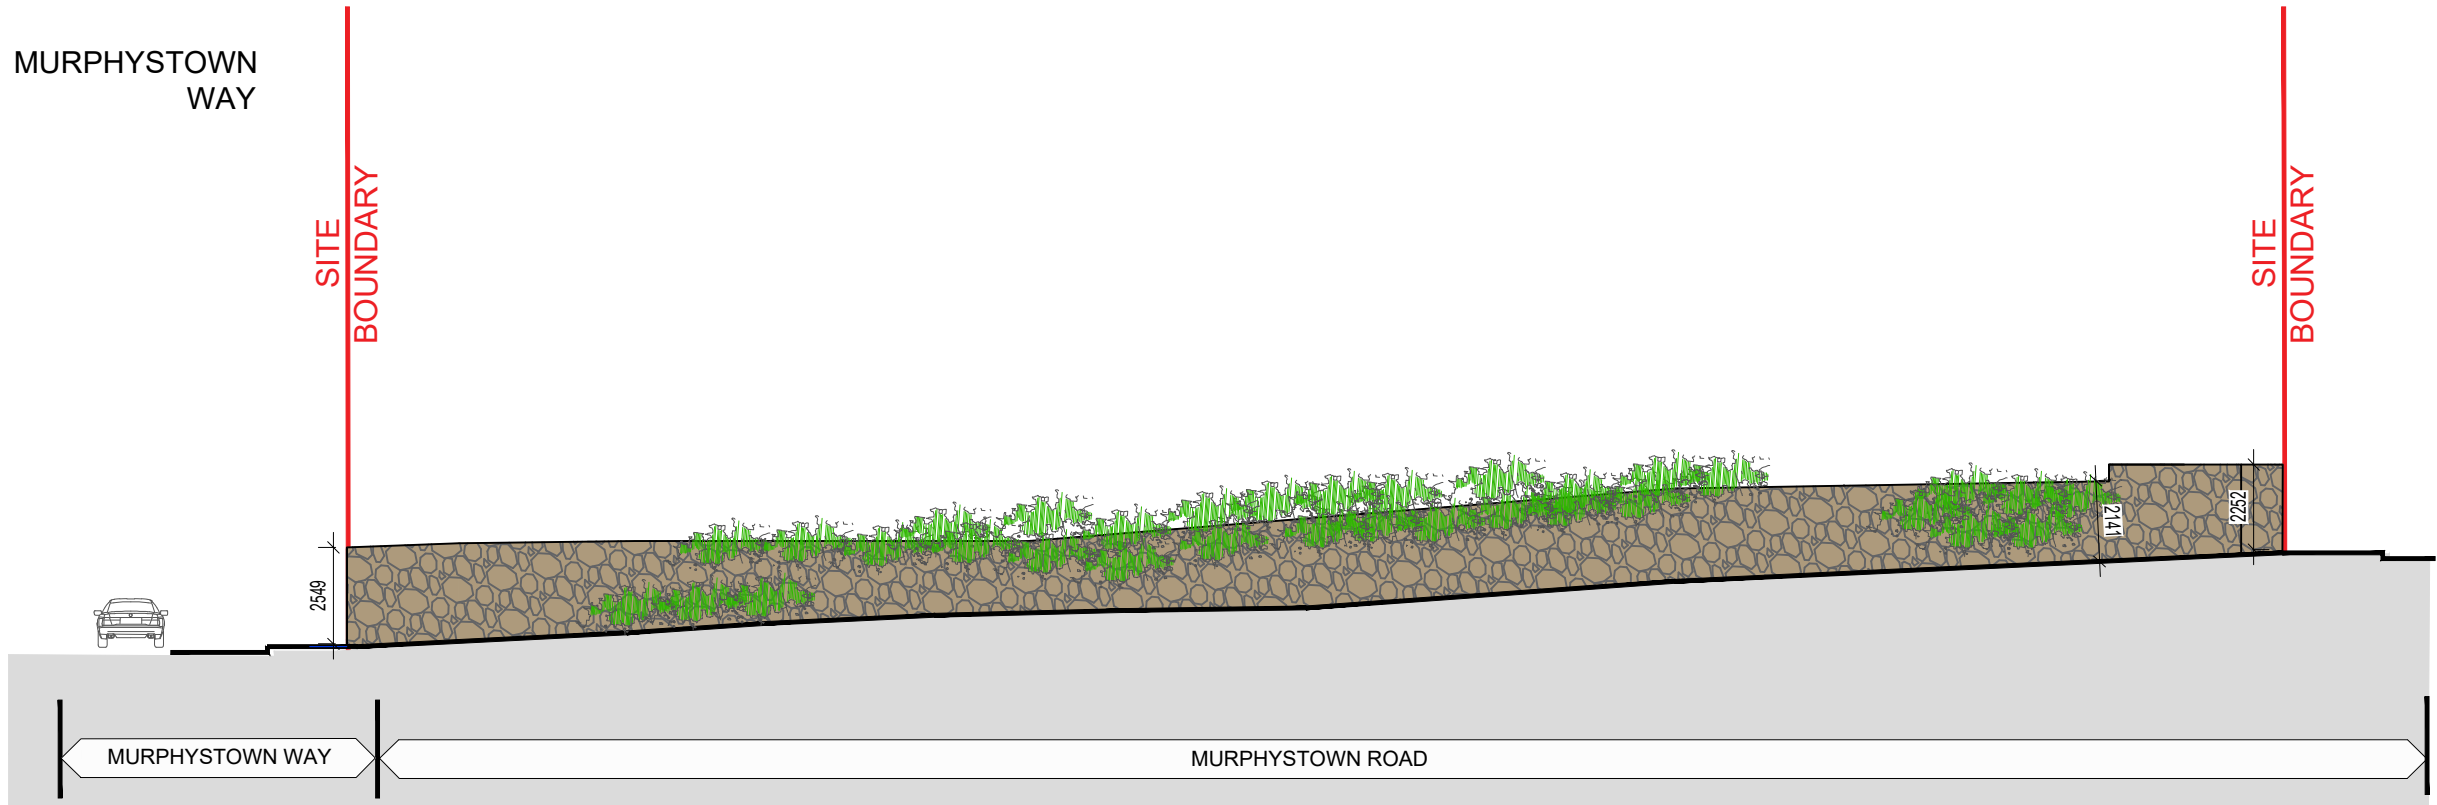

1 Existing Boundary Treatment from Murphystown Road  
2501 1:200


| BOUNDARY WALL LEGEND |                                                |
|----------------------|------------------------------------------------|
|                      | RANDOM RUBBLE NATURAL STONE CLAD CONCRETE WALL |
|                      | RENDERED CONCRETE BLOCKWORK WALL               |
|                      | NATURAL STONE WALL RENDERED                    |



2 Permitted Boundary Treatment from Murphystown Road  
2501 1:200 PERMITTED UNDER PLANNING APPLICATION ABP-307415-20 AND ITS SUBSEQUENT AMENDMENTS



3 Proposed Boundary Treatment from Murphystown Road  
2501 1:200

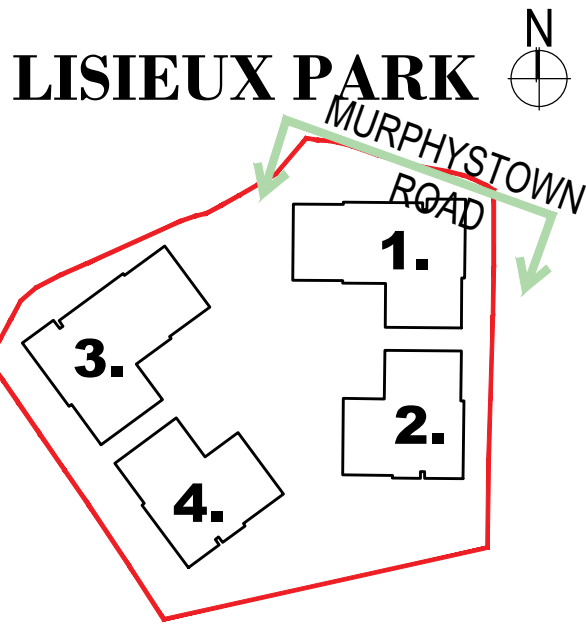

Permitted & Proposed

| Notes                                                                                                                                              |  |  |  |  | No. | Date     | Revision             | Initials |
|----------------------------------------------------------------------------------------------------------------------------------------------------|--|--|--|--|-----|----------|----------------------|----------|
| 1. Copyright Reserved                                                                                                                              |  |  |  |  | P01 | 09.07.24 | Planning Application | FF       |
| 2. Work to figured dimensions only. Do not scale drawing.                                                                                          |  |  |  |  |     |          |                      |          |
| 3. The contractor is responsible for checking all levels and dimensions on site and shall refer all discrepancies to the Architect                 |  |  |  |  |     |          |                      |          |
| 4. Where appropriate, for details of r.c. structure, or mechanical and electrical details, see Engineers drawings                                  |  |  |  |  |     |          |                      |          |
| 5. Proprietary items shall be fixed in strict accordance with manufacturers instructions.                                                          |  |  |  |  |     |          |                      |          |
| 6. Sizes of proprietary items shall be checked with manufacturer.                                                                                  |  |  |  |  |     |          |                      |          |
| 7. The contractor shall be responsible for the coordination of structure, finishes and services.                                                   |  |  |  |  |     |          |                      |          |
| M:\Project Section - Current\6275 Lisieux Hall\CAD\Planning\111 Boundary Walls Planning App\Boundary Walls Planning_Aug 24.dwg 12/09/2024 15:55:37 |  |  |  |  |     |          |                      |          |

| Issue Status         |   |
|----------------------|---|
| Progress             |   |
| Planning Application | ■ |
| Fire Cert            |   |
| Disability Cert      |   |
| Tender               |   |
| Construction         |   |
| As Built             |   |
| Information Only     |   |

| Project                                   |            | 6-7 HARDCOURT TERRACE, DUBLIN 2, IRELAND        |          |
|-------------------------------------------|------------|-------------------------------------------------|----------|
| RESIDENTIAL APARTMENTS, LISIEUX PARK      |            | 1 + 363-1-618 2100 1 + 363-1-678 7385           |          |
| Murphystown Road, Leopardstown, Dublin 18 |            | www.bkd.ie                                      |          |
| Drawing Title                             |            | Permitted and Proposed Boundary Walls Treatment |          |
| Stage                                     | Planning   | Scale                                           | 1:200@A1 |
| Drawn                                     | FF         | Appt                                            | SR       |
| Date                                      | 09/07/2024 | Sheet no.                                       | 2501     |
| Project Code                              | 6275       | status                                          | --       |
| job                                       | LIS        | origin                                          | BKD      |
| zone                                      | ZZ         | level                                           | DR       |
| type                                      | DR         | dis                                             | A        |
| rev                                       | P01        | rev                                             |          |

