


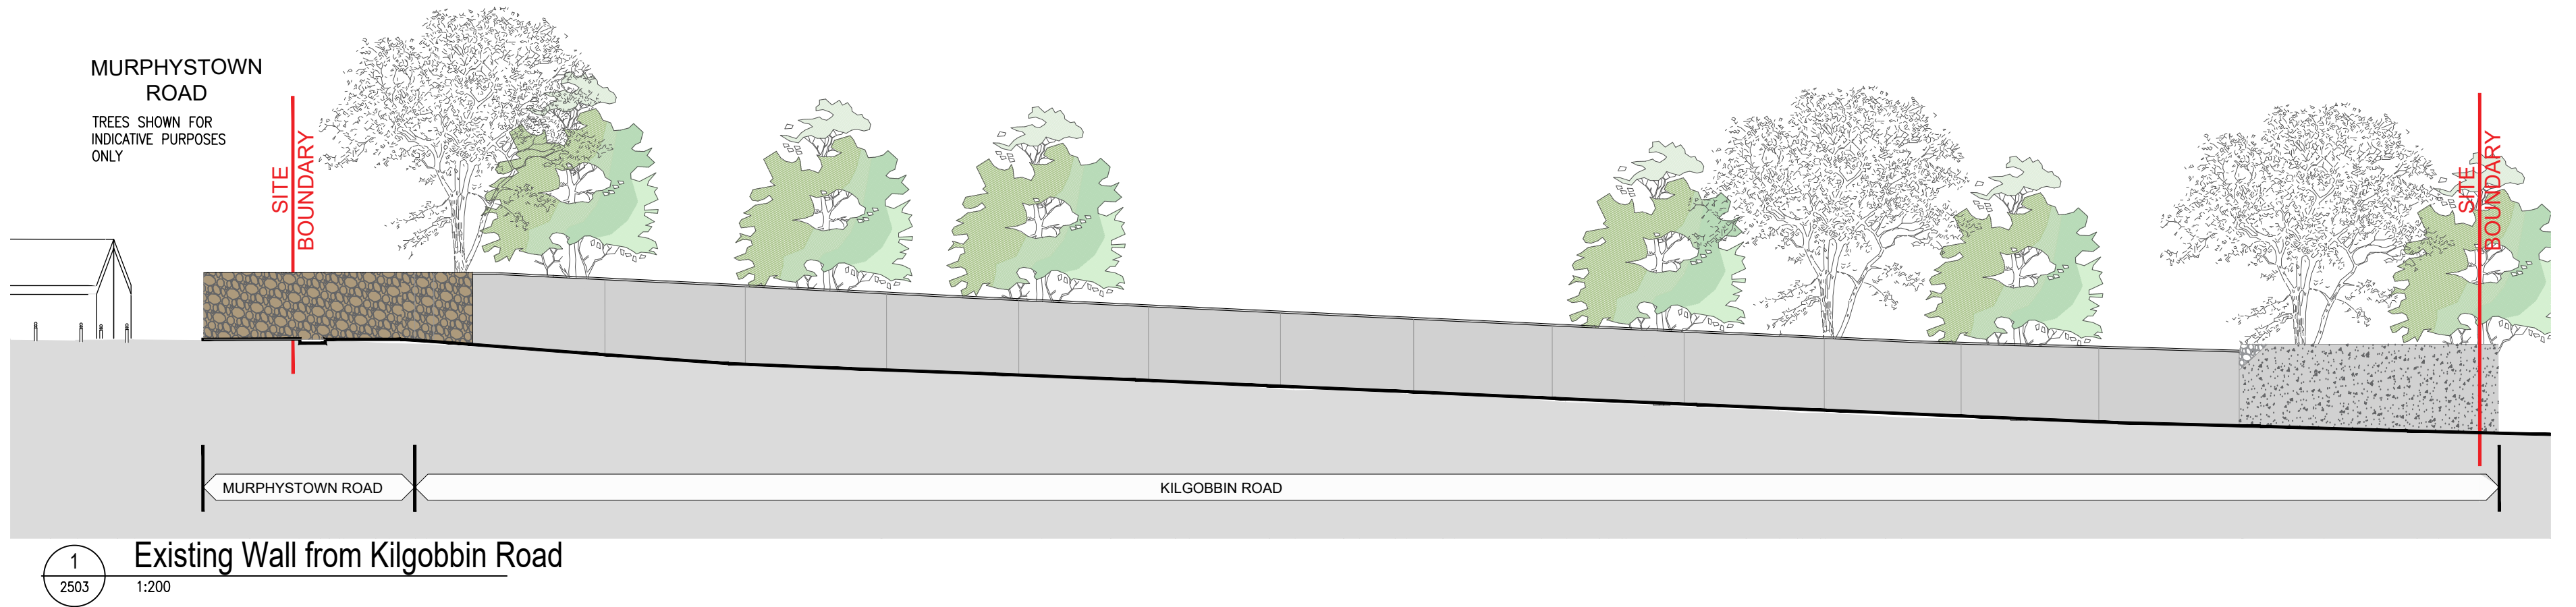


BOUNDARY WALL LEGEND	
	RANDOM RUBBLE NATURAL STONE CLAD CONCRETE WALL
	RENDERED CONCRETE BLOCKWORK WALL
	NATURAL STONE WALL RENDERED



2 Permitted Boundary Treatment from Kilgobbin Road
1:200 PERMITTED UNDER PLANNING APPLICATION ABP-307415-20 AND ITS SUBSEQUENT AMENDMENTS



3 Proposed Boundary Treatment from Kilgobbin Road
1:200

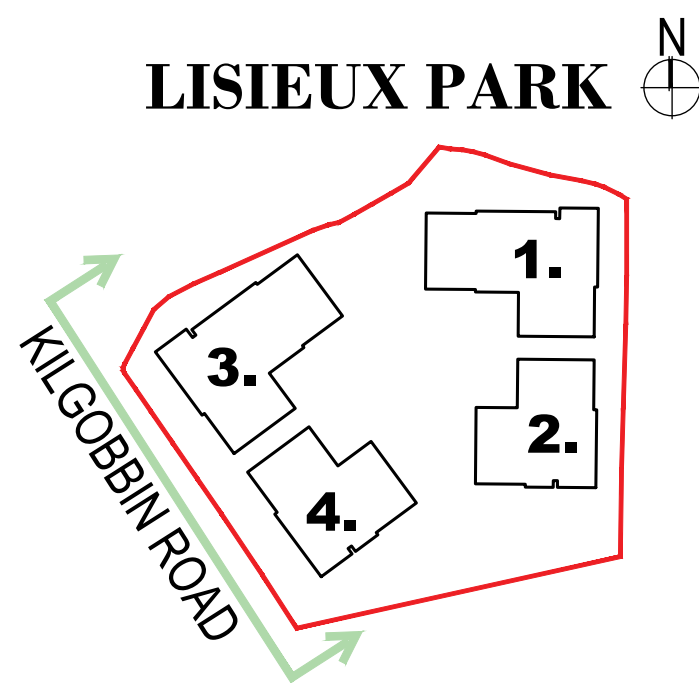

Permitted & Proposed

Notes		Issue Status		No.		Date		Revision		Initials	
1. Copyright Reserved		Progress		P01		09.07.24		Planning Application		FF	
2. Work to figure dimensions only. Do not scale drawing.		Planning Application									
3. The contractor is responsible for checking all levels and dimensions on site and shall refer all discrepancies to the Architect		Fire Cert									
4. Where appropriate, for details of r.c. structure, or mechanical and electrical details, see Engineers drawings		Disability Cert									
5. Proprietary items shall be fixed in strict accordance with manufacturers instructions.		Tender									
6. Sizes of proprietary items shall be checked with manufacturer.		Construction									
7. The contractor shall be responsible for the coordination of structure, finishes and services.		As Built									
M:\Project Section - Current\6275 Lisieux Hall\CAD\Planning\111 Boundary Walls Planning App\Boundary Walls Planning, Aug 24.dwg		Information Only									

Project		RESIDENTIAL APARTMENTS, LISIEUX PARK		6-7 HARDCOURT TERRACE, DUBLIN 2, IRELAND	
Drawing Title		Permitted and Proposed Boundary Walls Treatment		1 + 353-1-618 2400 1 + 353-1-678 7385	
Stage		Planning		www.bkd.ie	
Project Code		6275		bkdarchitects	
Job		LIS		BURKE-KENNEDY DOYLE	
Origin		BKO			
Zone		ZZ			
Level		ZZ			
Type		DR			
Dis		A			
Sheet no.		2503			
Status		--			
Rev		P01			